


NOTES: All measurements are in feet and inches

**LEGEND**

- Pearl White Marble
- White tile
- Wooden Planks
- Stone tile
- Ceramic Tiles

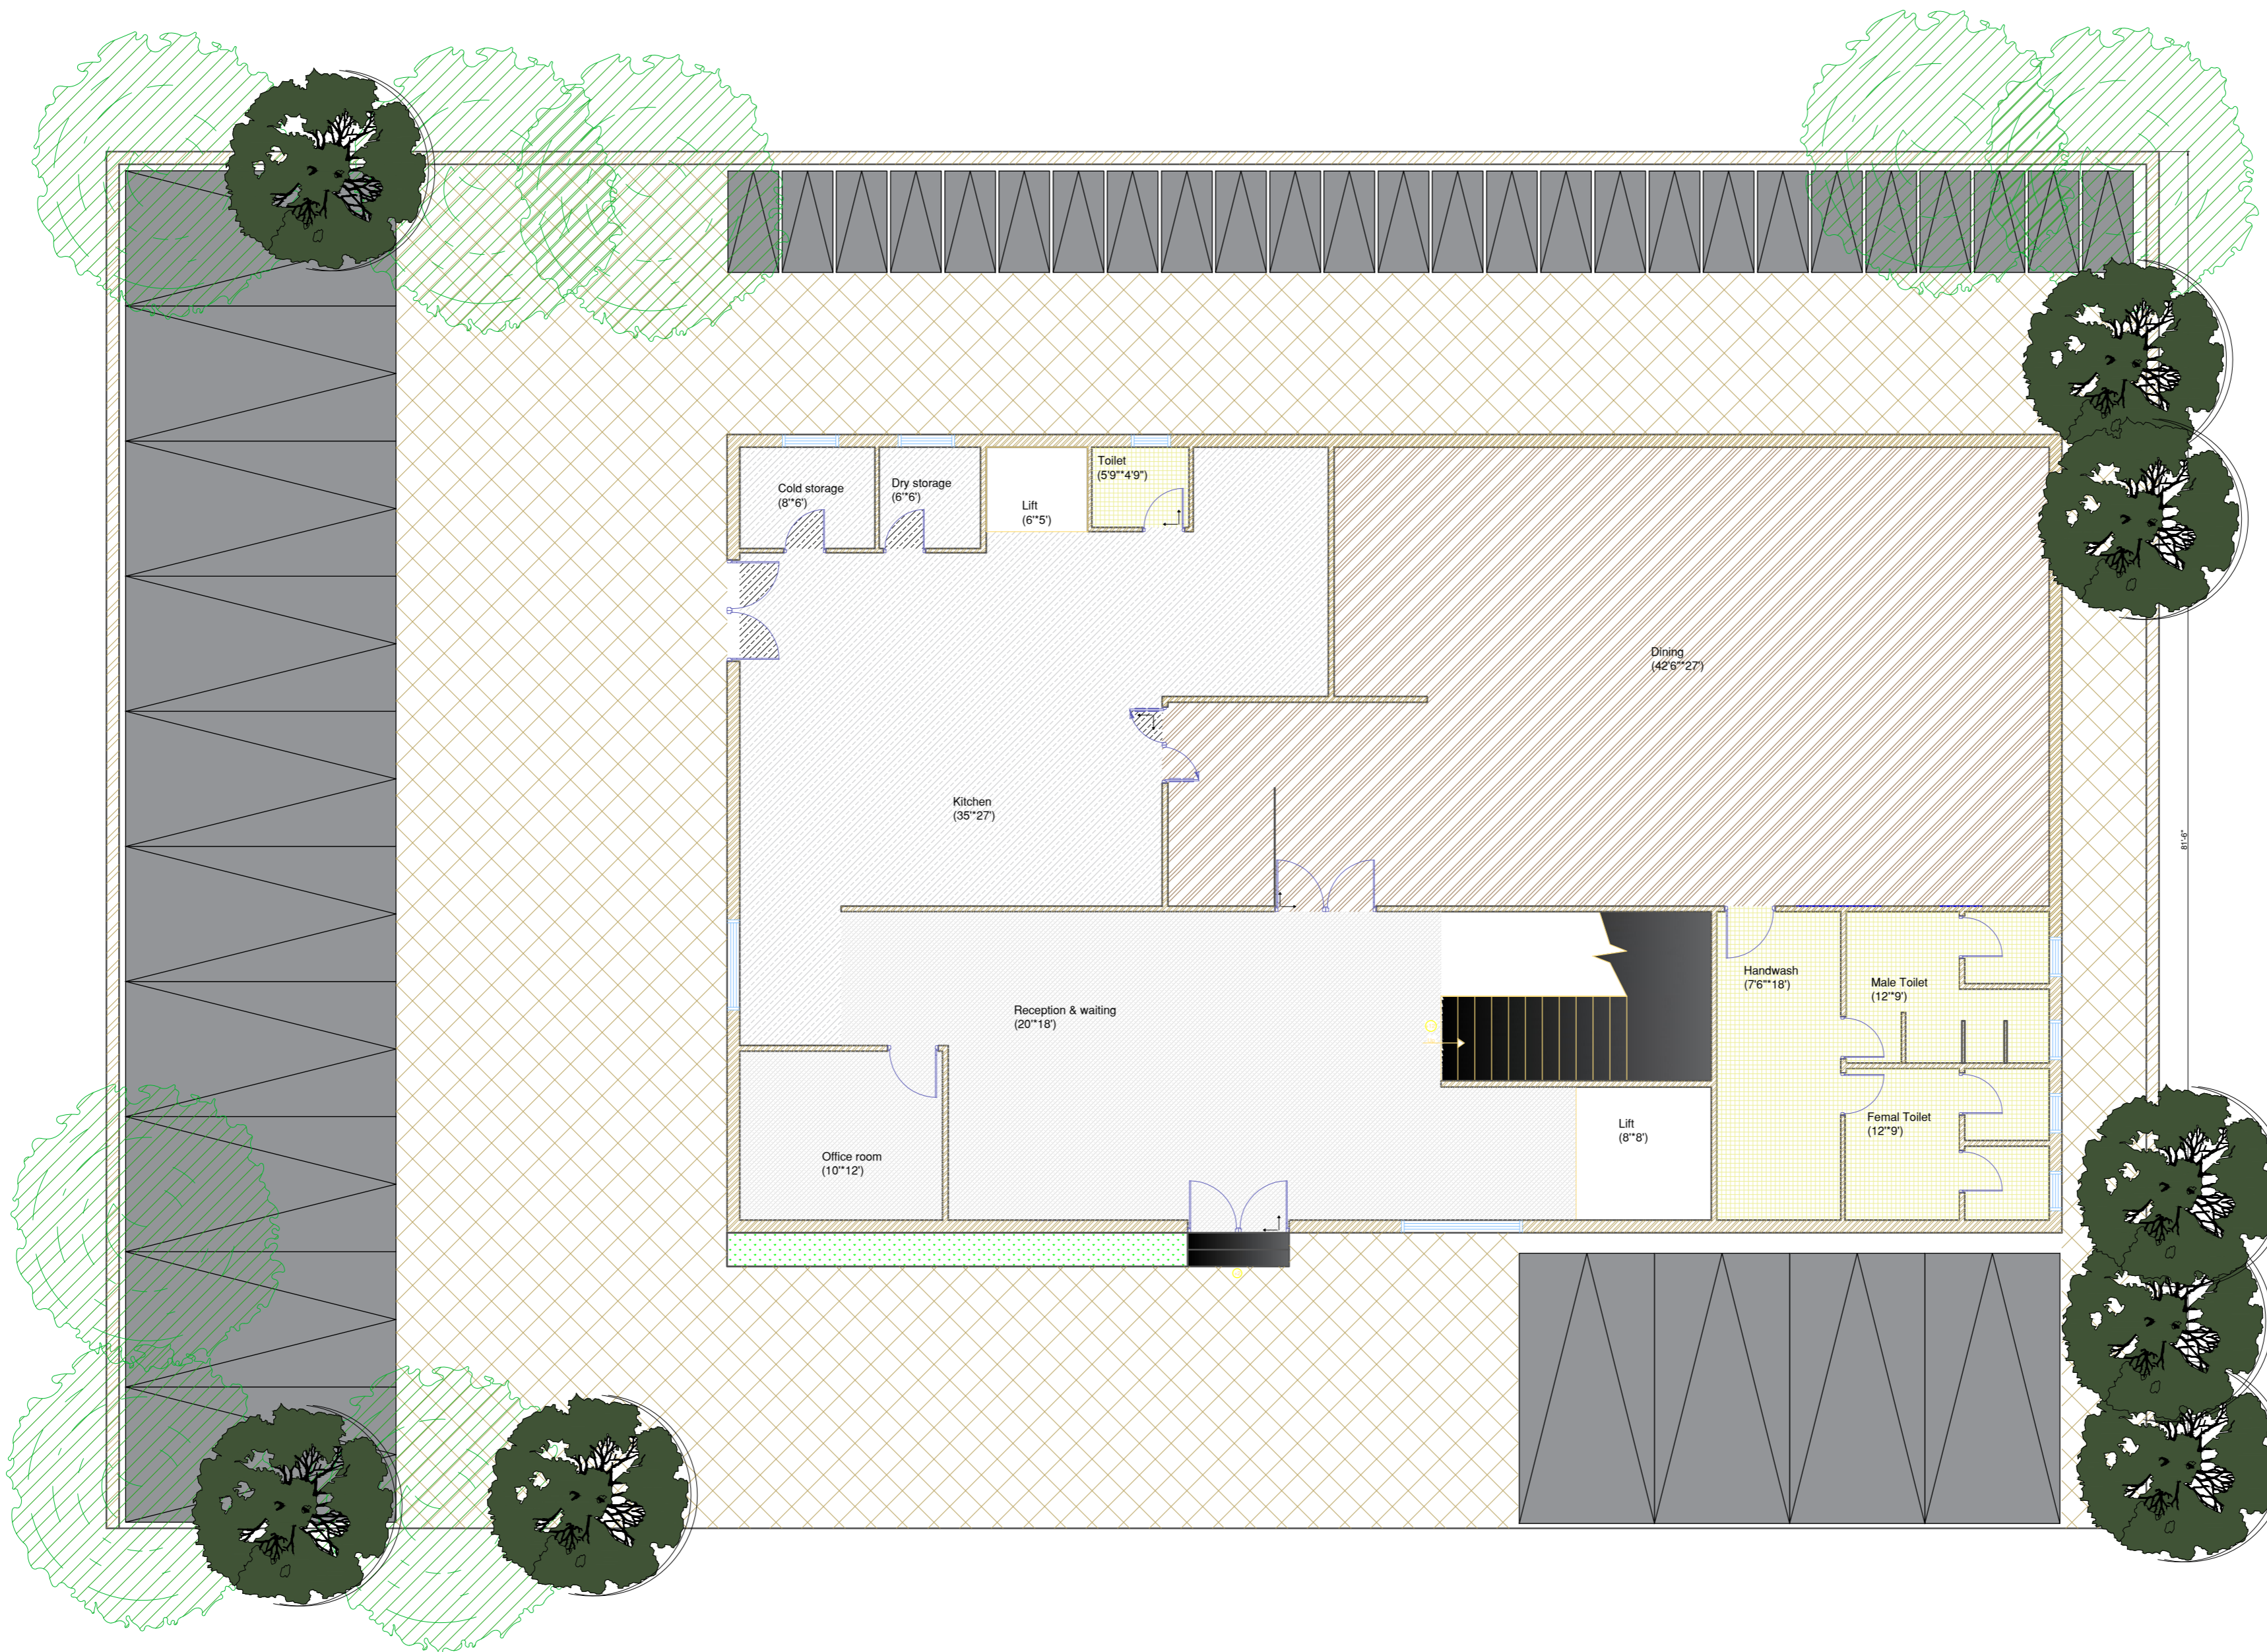

PROJECT NAME: Restaurant

CLIENT NAME: Santhosh Bantiya

DRAWING NAME: Electrical Plan

NAME: Vigya.M

DATE: 25-03-19

SHEET NUMBER:

SCALE: 1:70

**06**