


NOTES: All measurements are in feet and inches

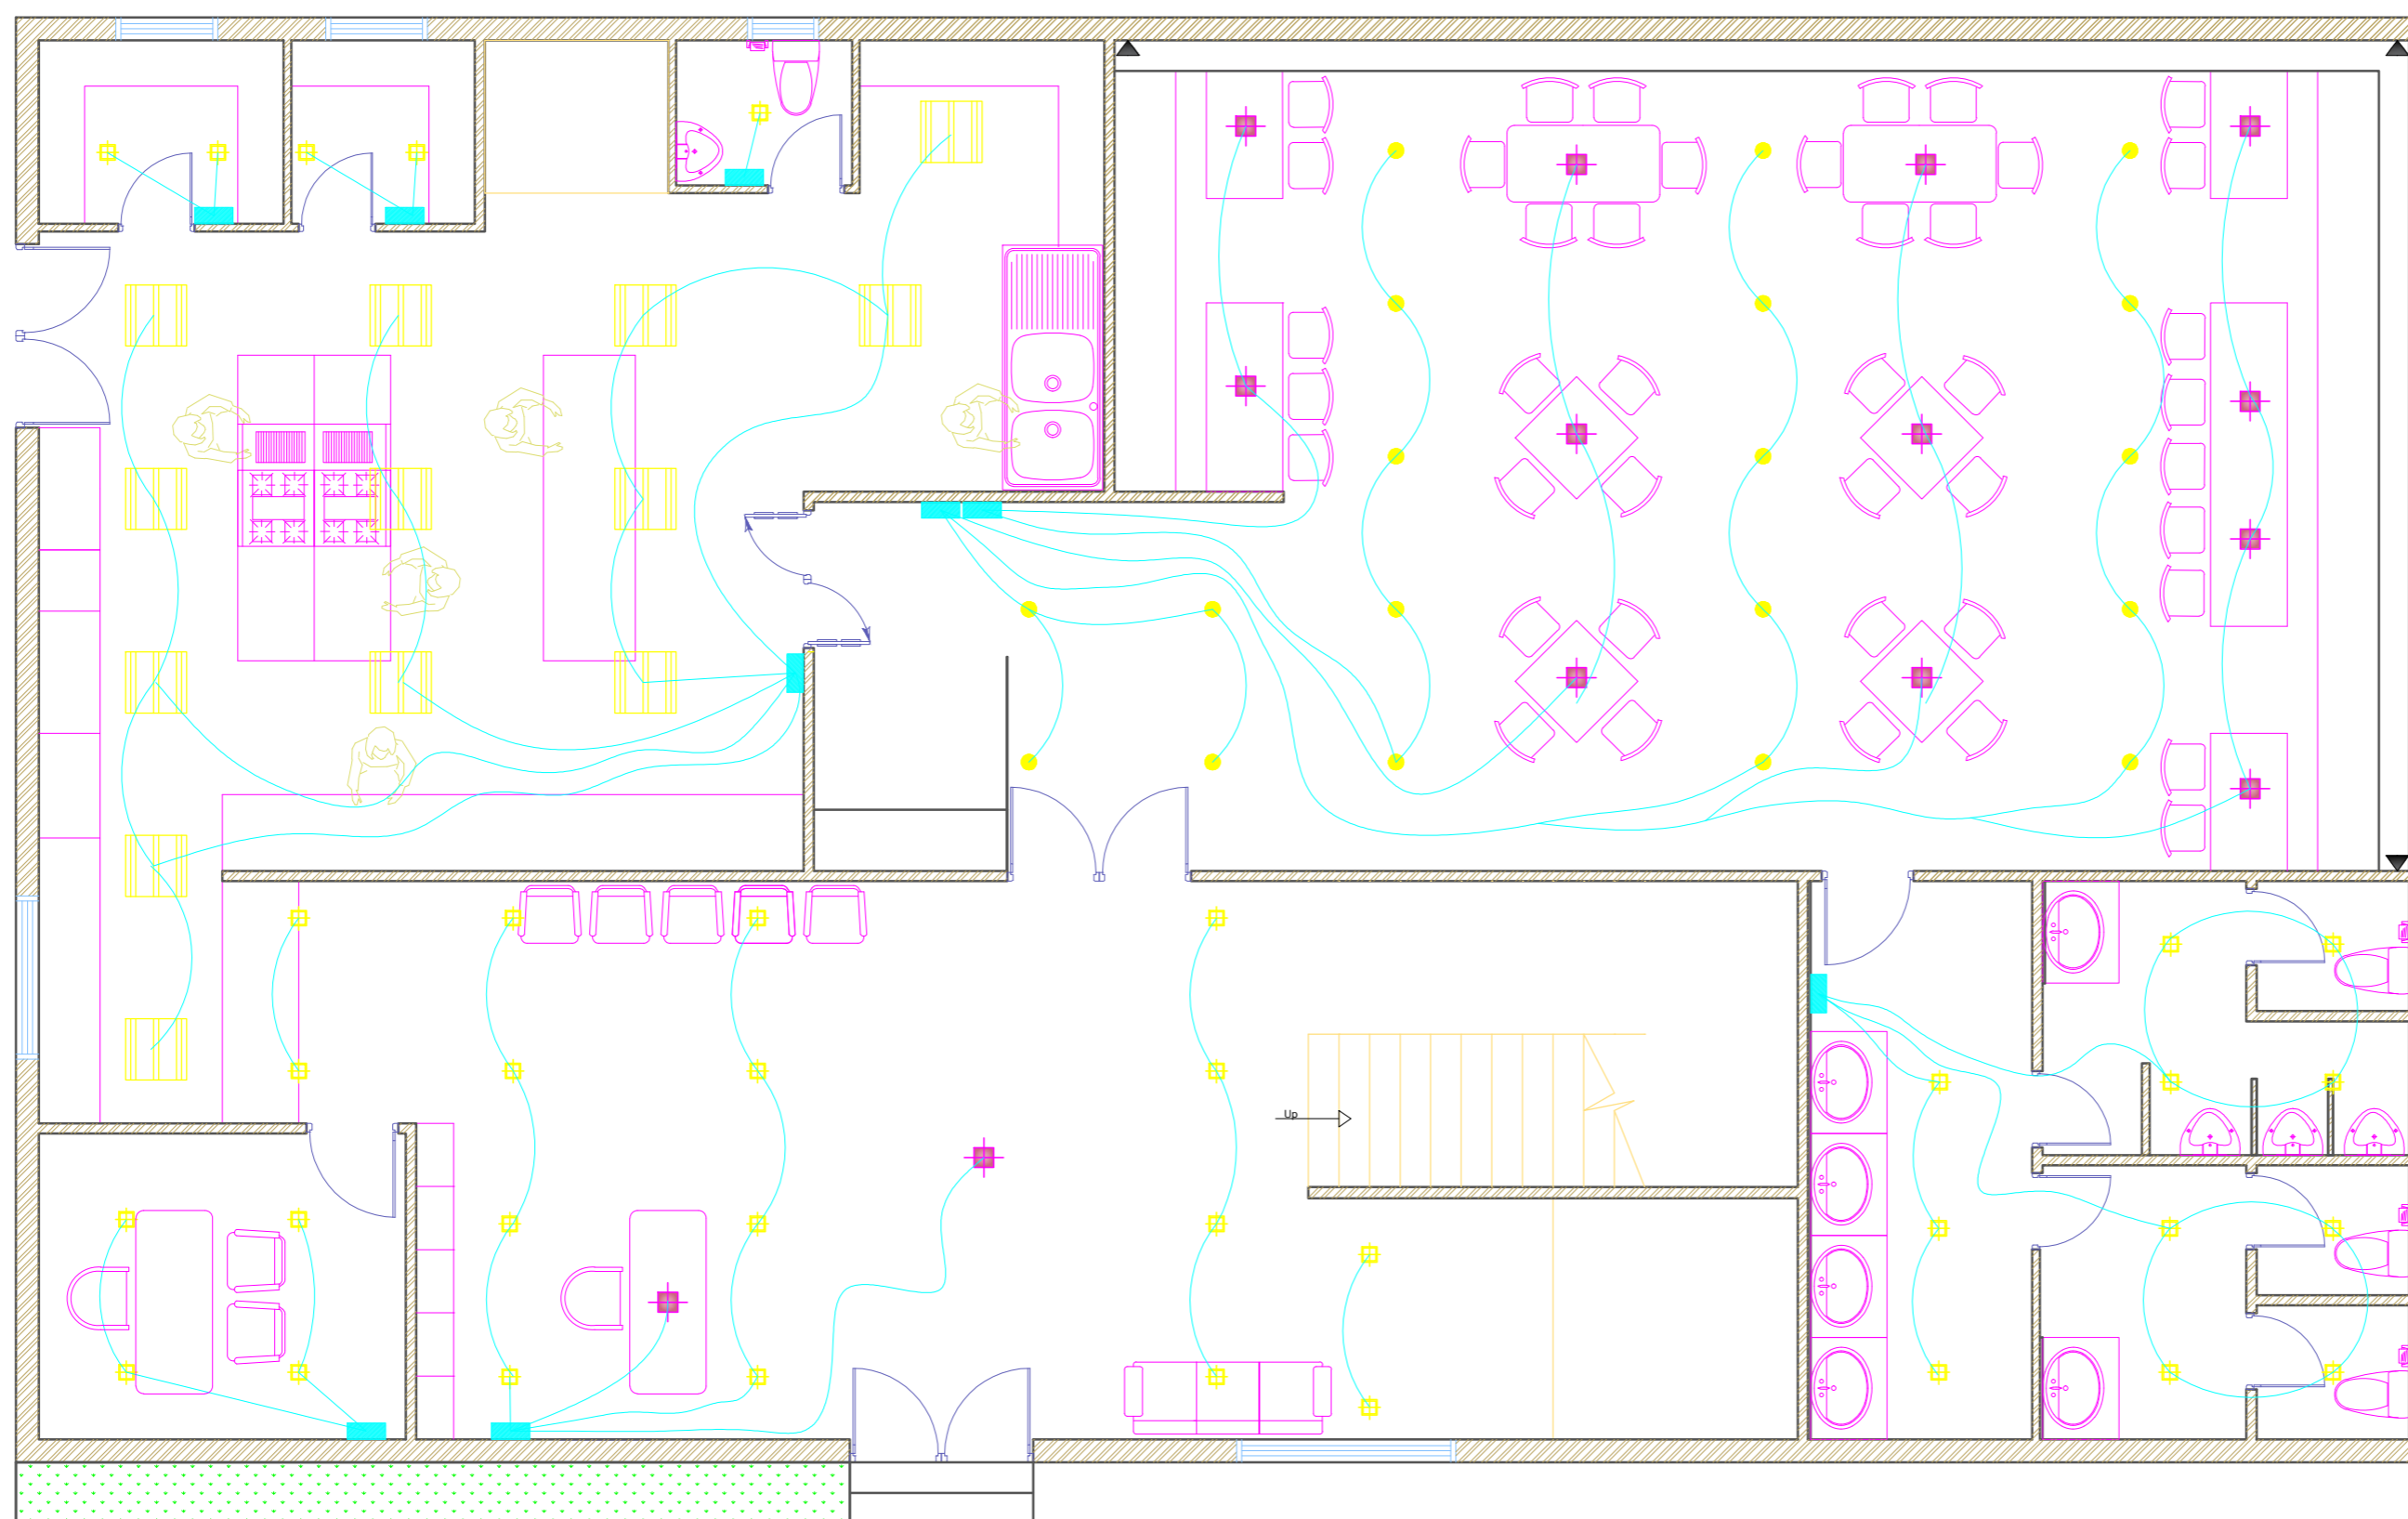

LEGEND

- Switch Module
- Concealed square lights
- Concealed round lights
- Pendant lights
- Wire

PROJECT NAME: Restaurant

CLIENT NAME: Santhosh Bantiya

DRAWING NAME: Ground floor
Electrical Plan

NAME: Vigya.M

DATE: 25-03-19

SHEET
NUMBER:

SCALE: 1:70

08