


NOTES: All measurements are in feet and inches

LEGEND

- Switch Module
- Concealed square lights
- Concealed round lights
- Pendant lights
- Wire

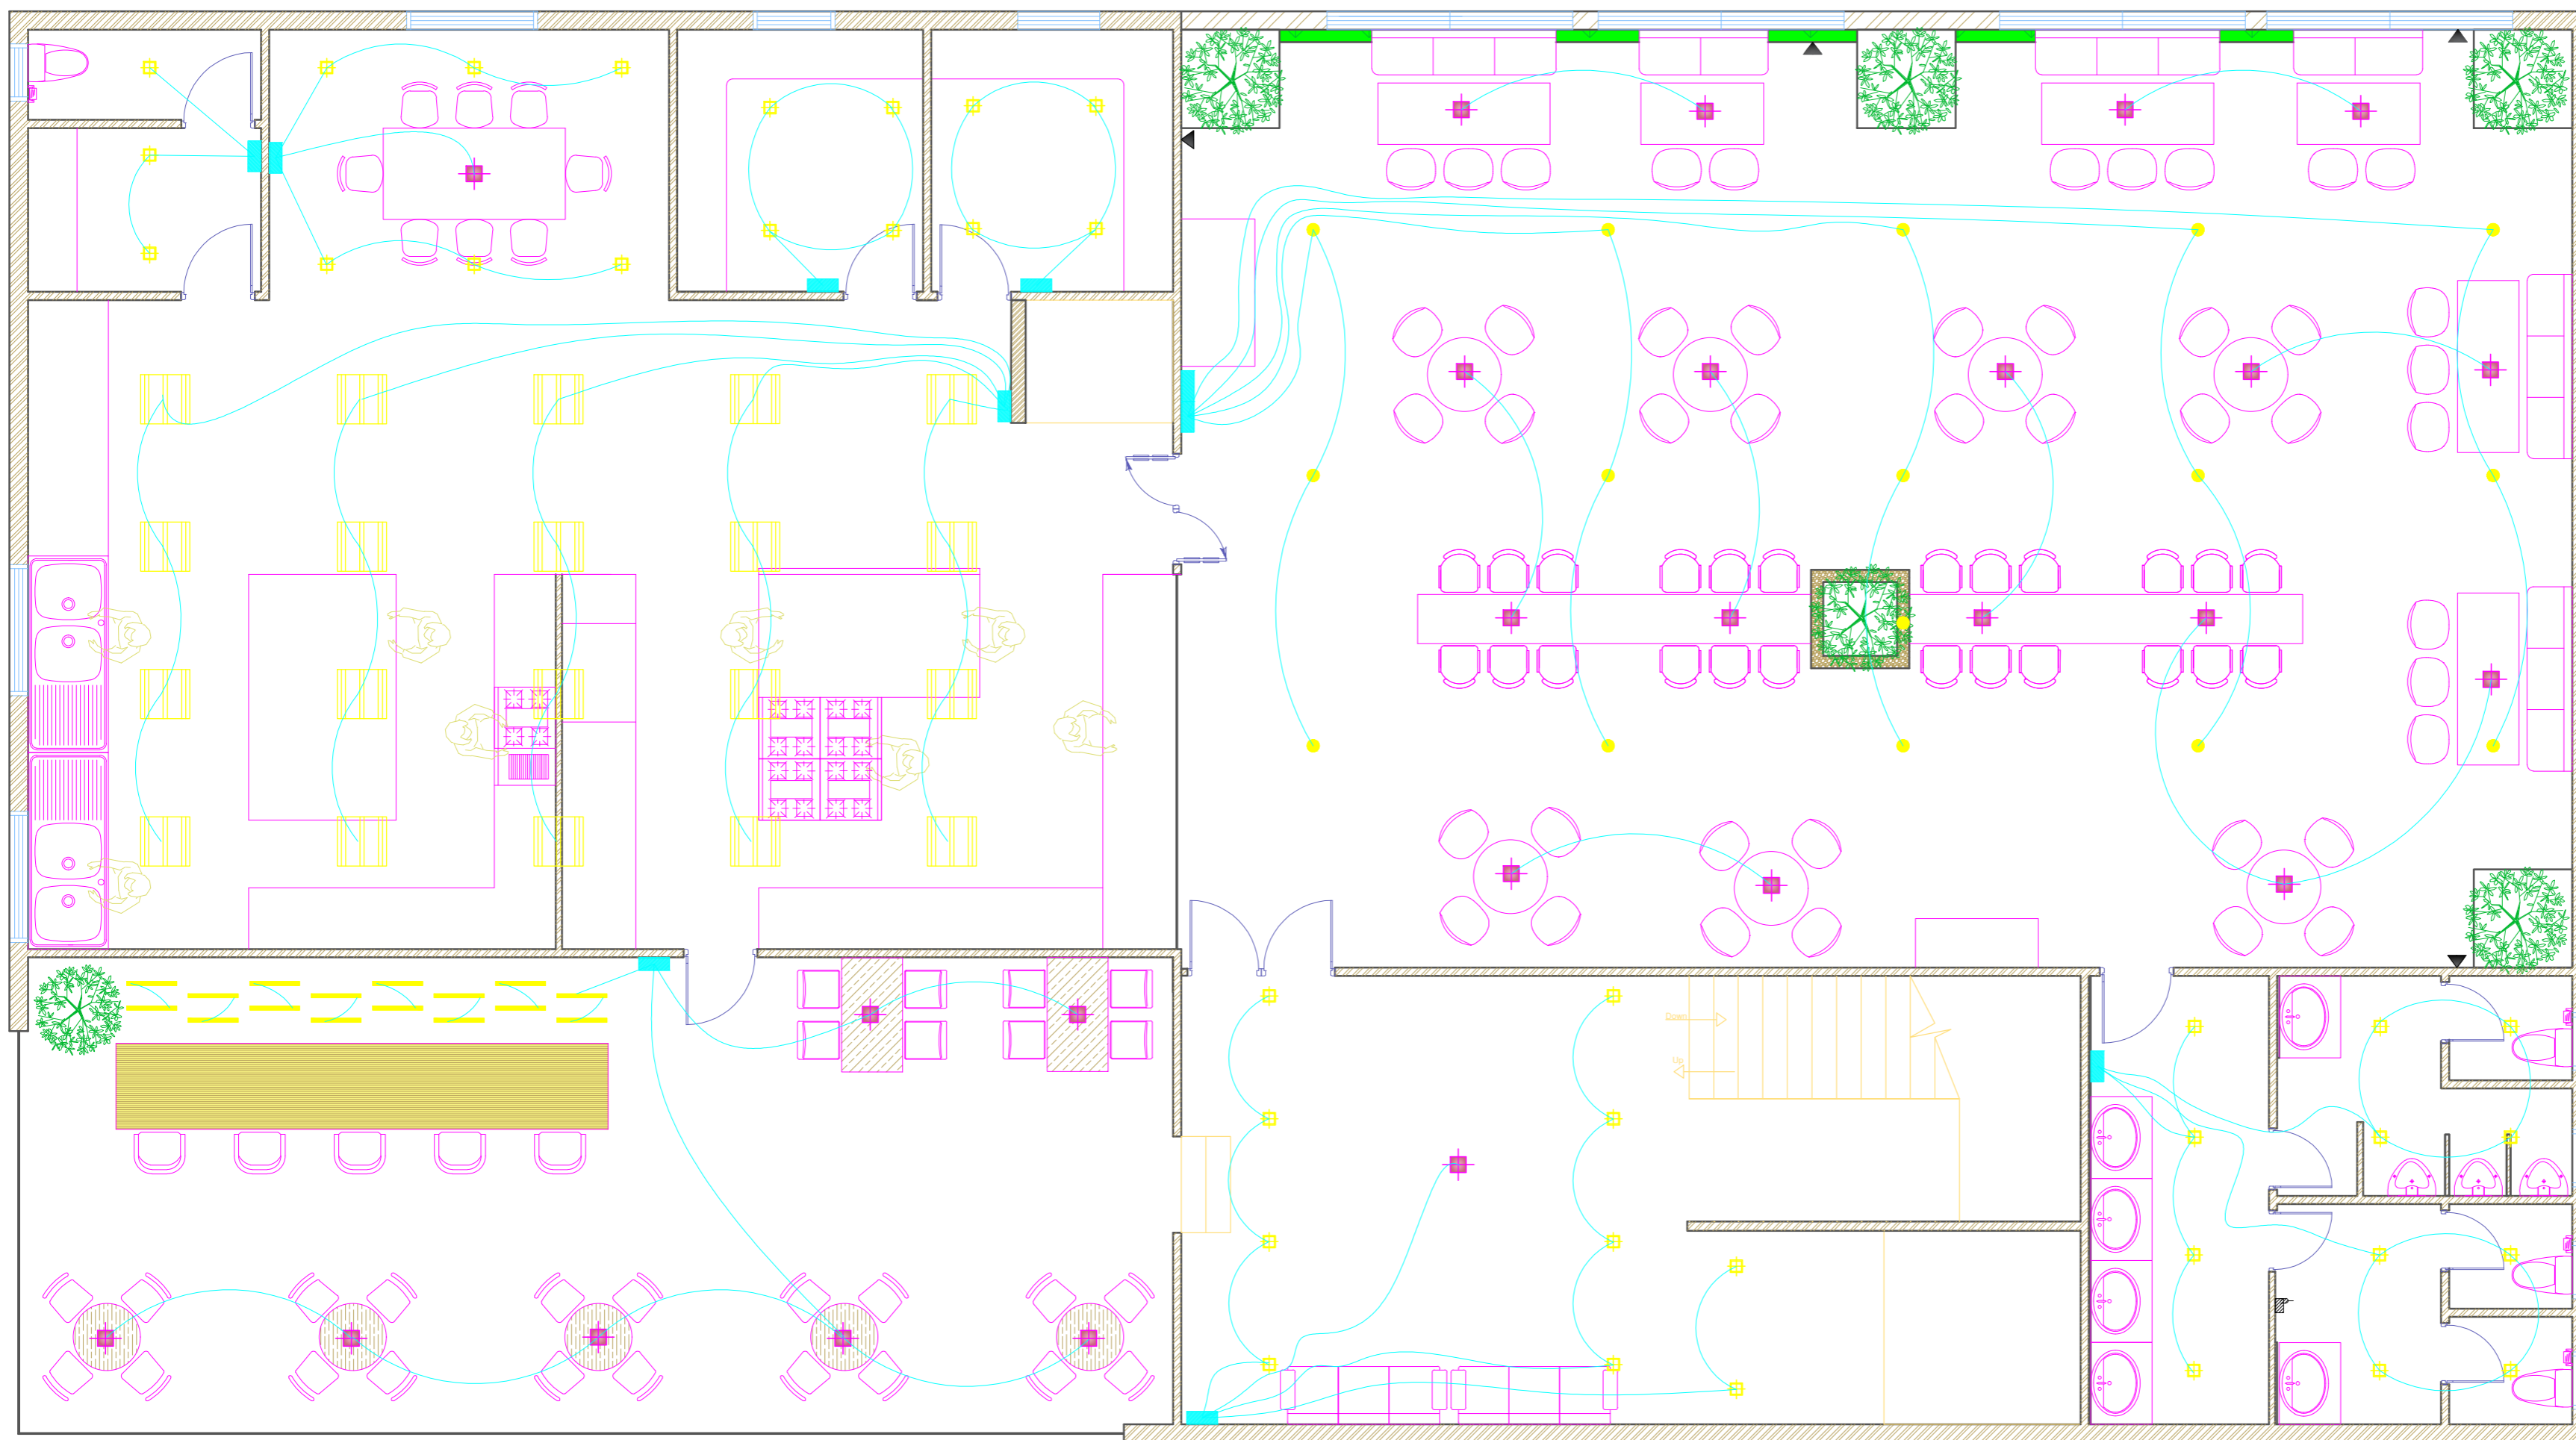

PROJECT NAME: Restaurant

CLIENT NAME: Santhosh Bantiya

DRAWING NAME: First floor Electrical Plan

NAME: Vigya.M

DATE: 25-03-19

SHEET NUMBER:

SCALE: 1:70

09